

FIRST FLOOR PLAN - ELECTRICAL


ELECTRICAL SYMBOLS LIST

⊙	NEW INCANDESCENT FUTURE	⊕	NEW DUPLEX RECEPTACLE
⊙	REMOVE EXISTING INCANDESCENT FUTURE	⊕	REMOVE EXISTING RECEPTACLE
⊙	EXISTING INCANDESCENT FUTURE, REINSTALLED	⊕	EXISTING DUPLEX RECEPTACLE, REINSTALLED
⊙	NEW FLUORESCENT FUTURE	⊕	EXISTING FAN OUTLET WITH SWITCH & RECEPTACLE
⊙	REMOVE EXISTING FLUORESCENT FUTURE	⊕	BLANK EXISTING OUTLET
⊙	EXISTING FLUORESCENT FUTURE, REINSTALLED	⊕	BLANK EXISTING NIGHT LIGHT
⊙	NEW FLUORESCENT STRIP LIGHT	⊕	WIRING CONCEALED IN CEILING OR WALL
⊙	NEW SINGLE POLE SWITCH	⊕	WIRING CONCEALED IN FLOOR
⊙	REMOVE SINGLE POLE SWITCH	⊕	BRANCH CIRCUIT EXPOSED
⊙	EXISTING SINGLE POLE SWITCH, REINSTALLED	⊕	BRANCH CIRCUIT HOME RUN TO PANEL BOARD, CHANGE OF NUMBER OF WIRES IN CONDUIT
⊙	NEW THREE WAY SWITCH	⊕	NEW WIREMOLD
⊙	REMOVE THREE WAY SWITCH	⊕	EXISTING WIREMOLD
⊙	EXISTING THREE WAY SWITCH	⊕	PANEL BOARD NEW
⊙	NEW KEY SWITCH	⊕	AC ABOVE COUNTER
⊙	REMOVE KEY SWITCH	⊕	WP WEATHER PROOF
⊙	EXISTING KEY SWITCH	⊕	APR ABOVE FINISHED FLOOR
⊙	NEW SWITCH WITH PILOT LIGHT	⊕	JB JUNCTION BOX
⊙	REMOVE SWITCH WITH PILOT LIGHT	⊕	INC INCANDESCENT
⊙	EXISTING SWITCH WITH PILOT LIGHT	⊕	FLOOR FLUORESCENT
⊙	WORK INSTALL AFFILIATE COMPARTMENT FOR SPECIAL OUTLET	⊕	PC PULL CHAIN

THIRD FL.

NOTE: ALL EXISTING FEEDERS TO REMAIN

NOTE: WIRES INDICATED ON THIS DWG. ARE NEW

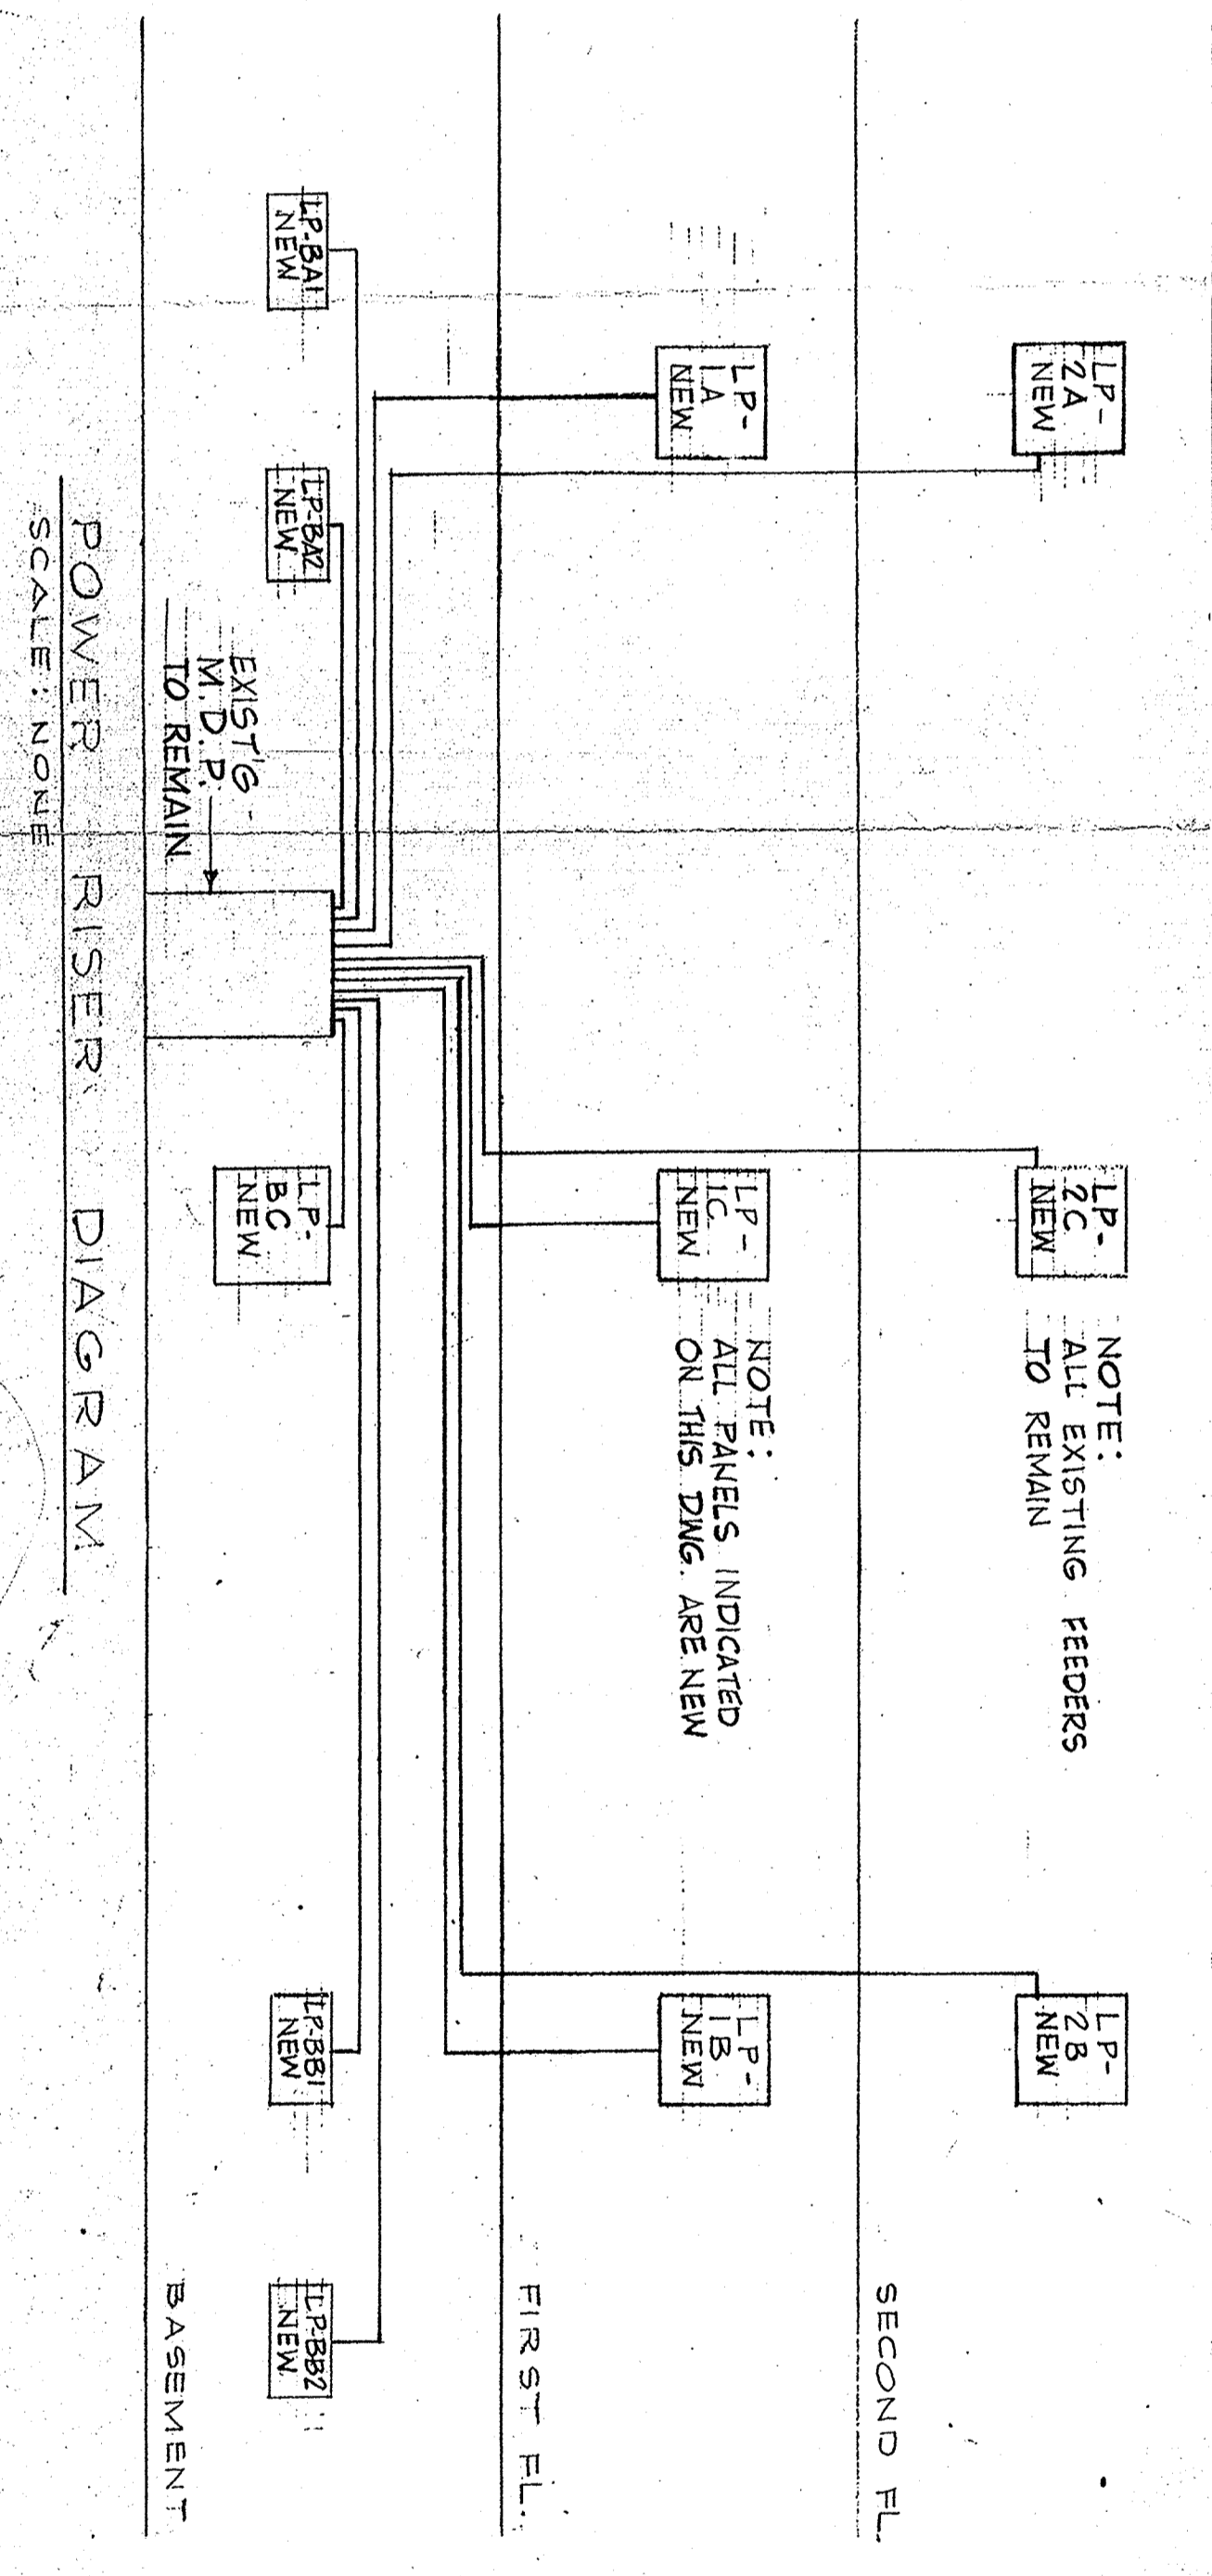

THE FAIRFIELD HILLS STATE HOSPITAL
STATE OF CONNECTICUT
BUREAU OF PUBLIC WORKS

NO.	REVISIONS	DATE

DESIGNED	DATE	PROJECT NO.
CHECKED		
APPROVED		
S.I.T.		

ELECTRICAL

FIRST FLOOR PLAN

SHELTON HOUSE

TIZIAN ENGINEERING ASSOCIATES, INC.
CONSULTING ENGINEERS
39 PROSPECT ST. STAMFORD, CONN.

SCALE 1/8"=1'-0"

DATE APRIL 1ST - 1983