




SAMFORD

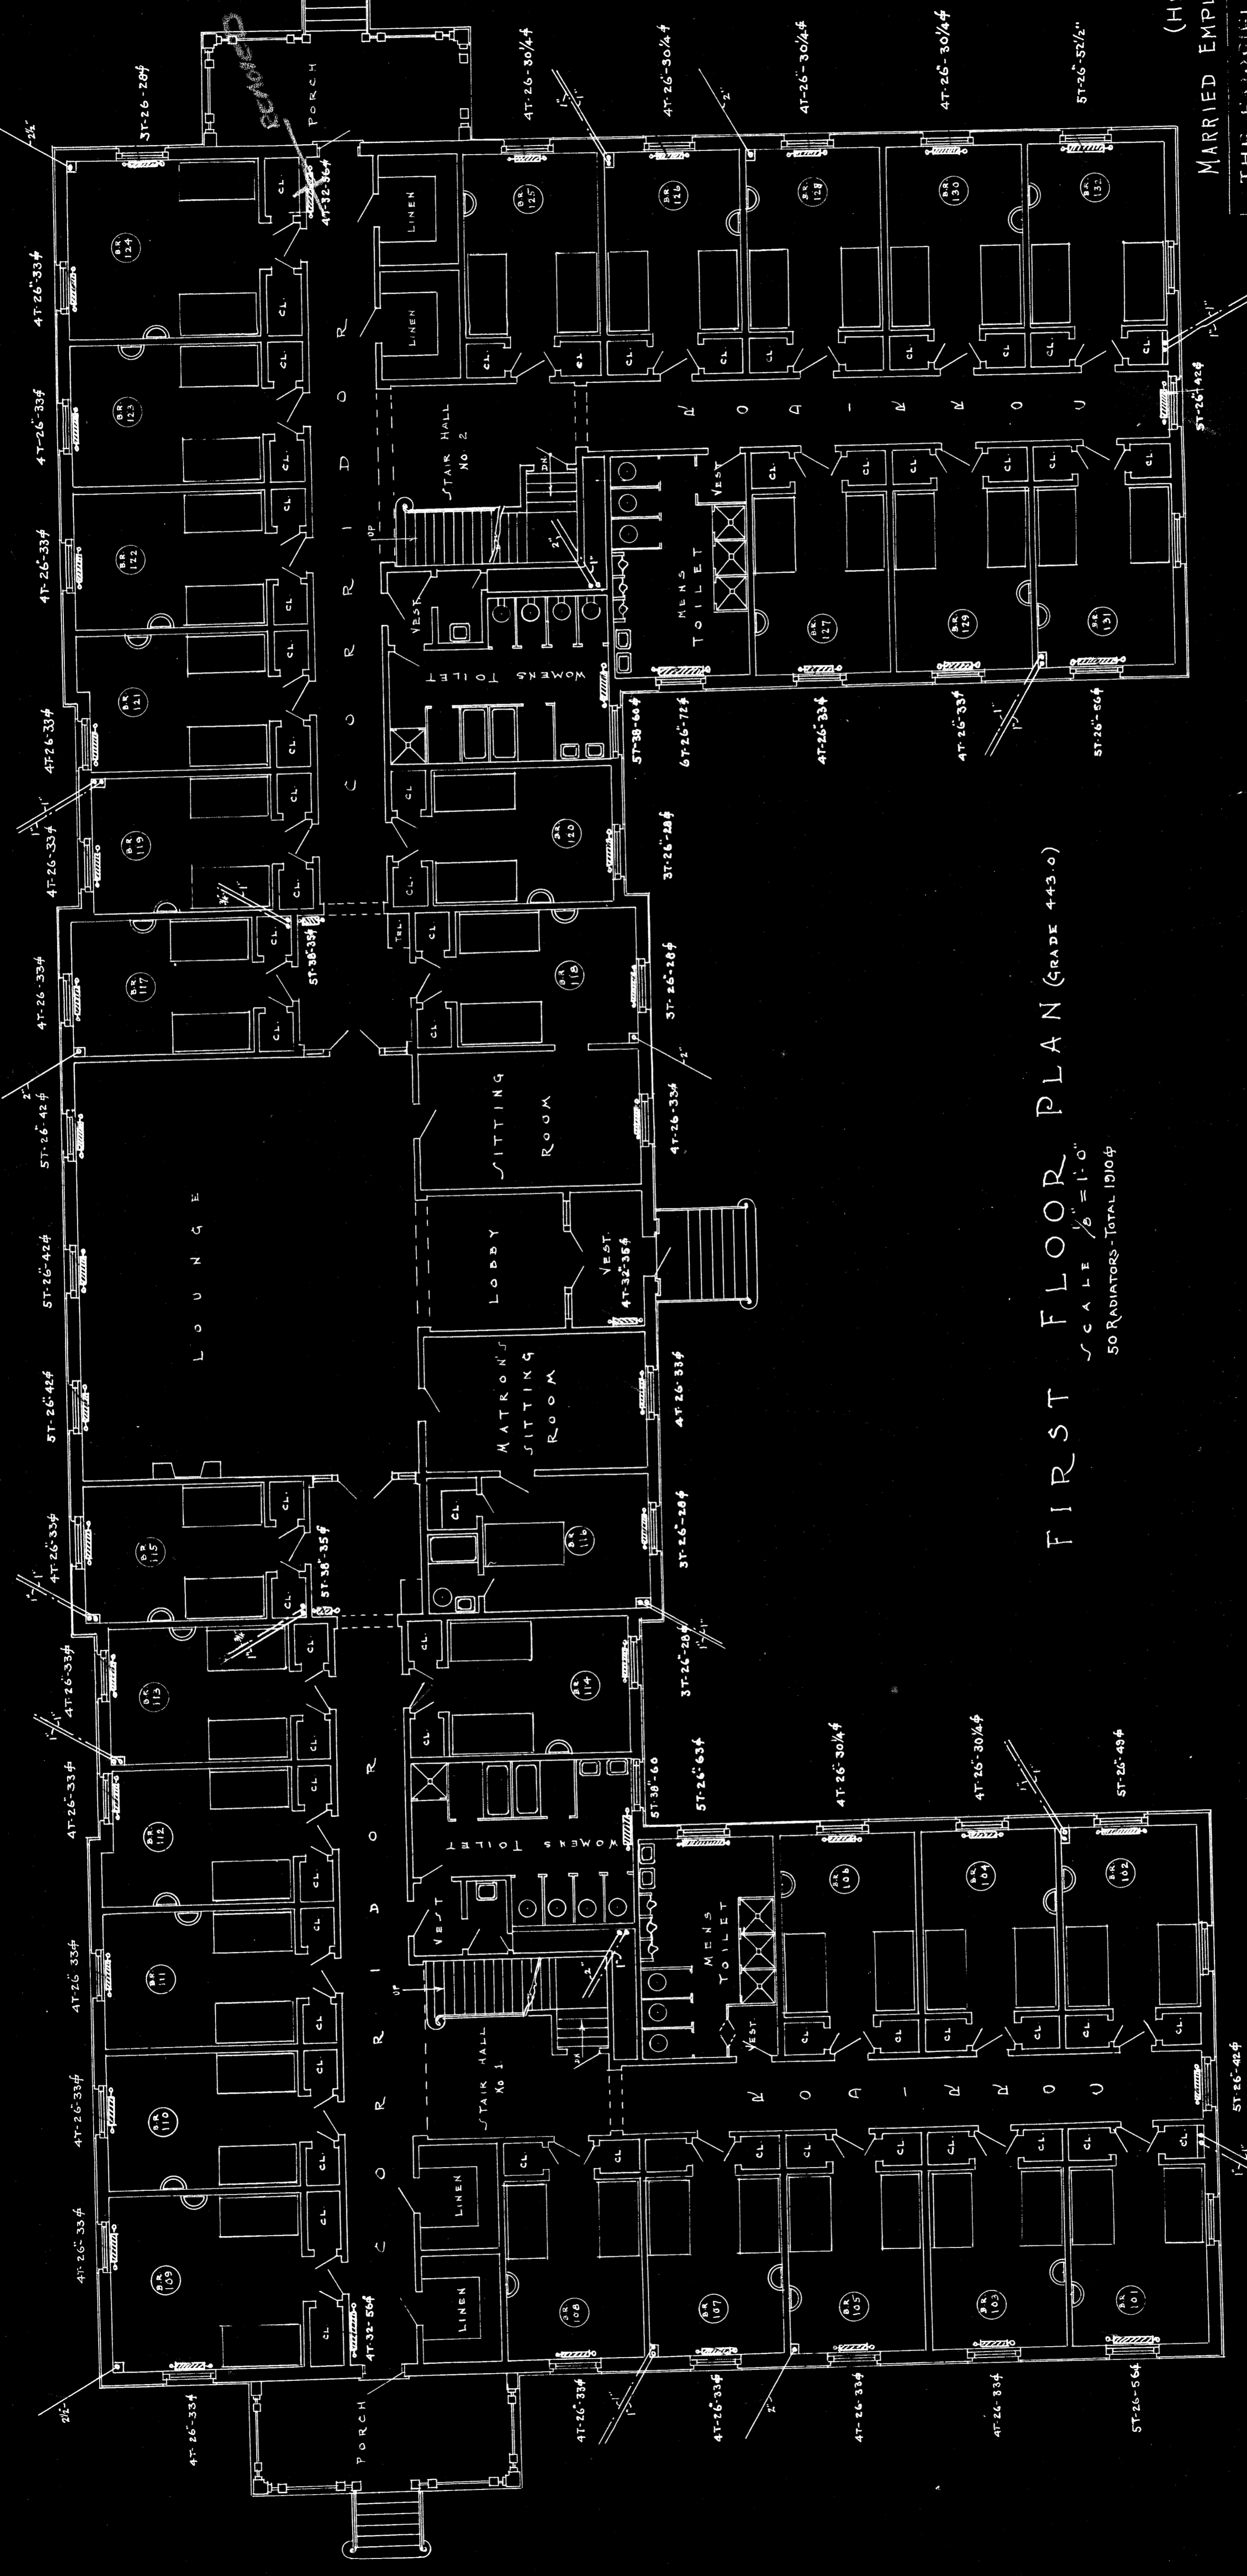

FIRST FLOOR PLAN (GRADE 443.0)

SCALE 1/8" = 1'-0"

50 RADIATORS TOTAL 19104

(HEATING)

MARRIED EMPLOYEES BLDG NO 22

THE FAIRFIELD STATE HOSPITAL
NEWTOWN, CONN.

Drawn by: WALTER P. UNDERHILL
Checked by: WALTER P. UNDERHILL
Designed by: WALTER P. UNDERHILL
Approved: WALTER P. UNDERHILL
STONE-UNDERHILL COMPANY, ENGINEERS
171 HARRISON AVENUE, NEWTOWN, MASS.

22H2

